



**DEVICE LEGEND**

- [FACP] FIRE ALARM CONTROL PANEL
- [FAPB] FIRE ALARM POWER BOOSTER
- [PSB] POWER SUPPLY DOOR HOLDERS
- [CANM] FIRE ALARM ANNUNCIATOR
- [PULL] PULL STATION
- [MDO] MAGNETIC DOOR HOLDER
- [SD] SMOKE DETECTOR
- [HTD] HEAT DETECTOR
- [HORN] HORN/STROBE
- [STROBE] STROBE
- [TS] TAMPER SWITCH (BY OTHERS)
- [FS] FLOW SWITCH (BY OTHERS)
- [PIV] POST INDICATOR VALVE (BY OTHERS)
- [MM] MONITOR MODULE
- [DD] DUCT DETECTOR
- [CM] CONTROL MODULE
- [R] 24V. RELAY (SMOKE DAMPERS)

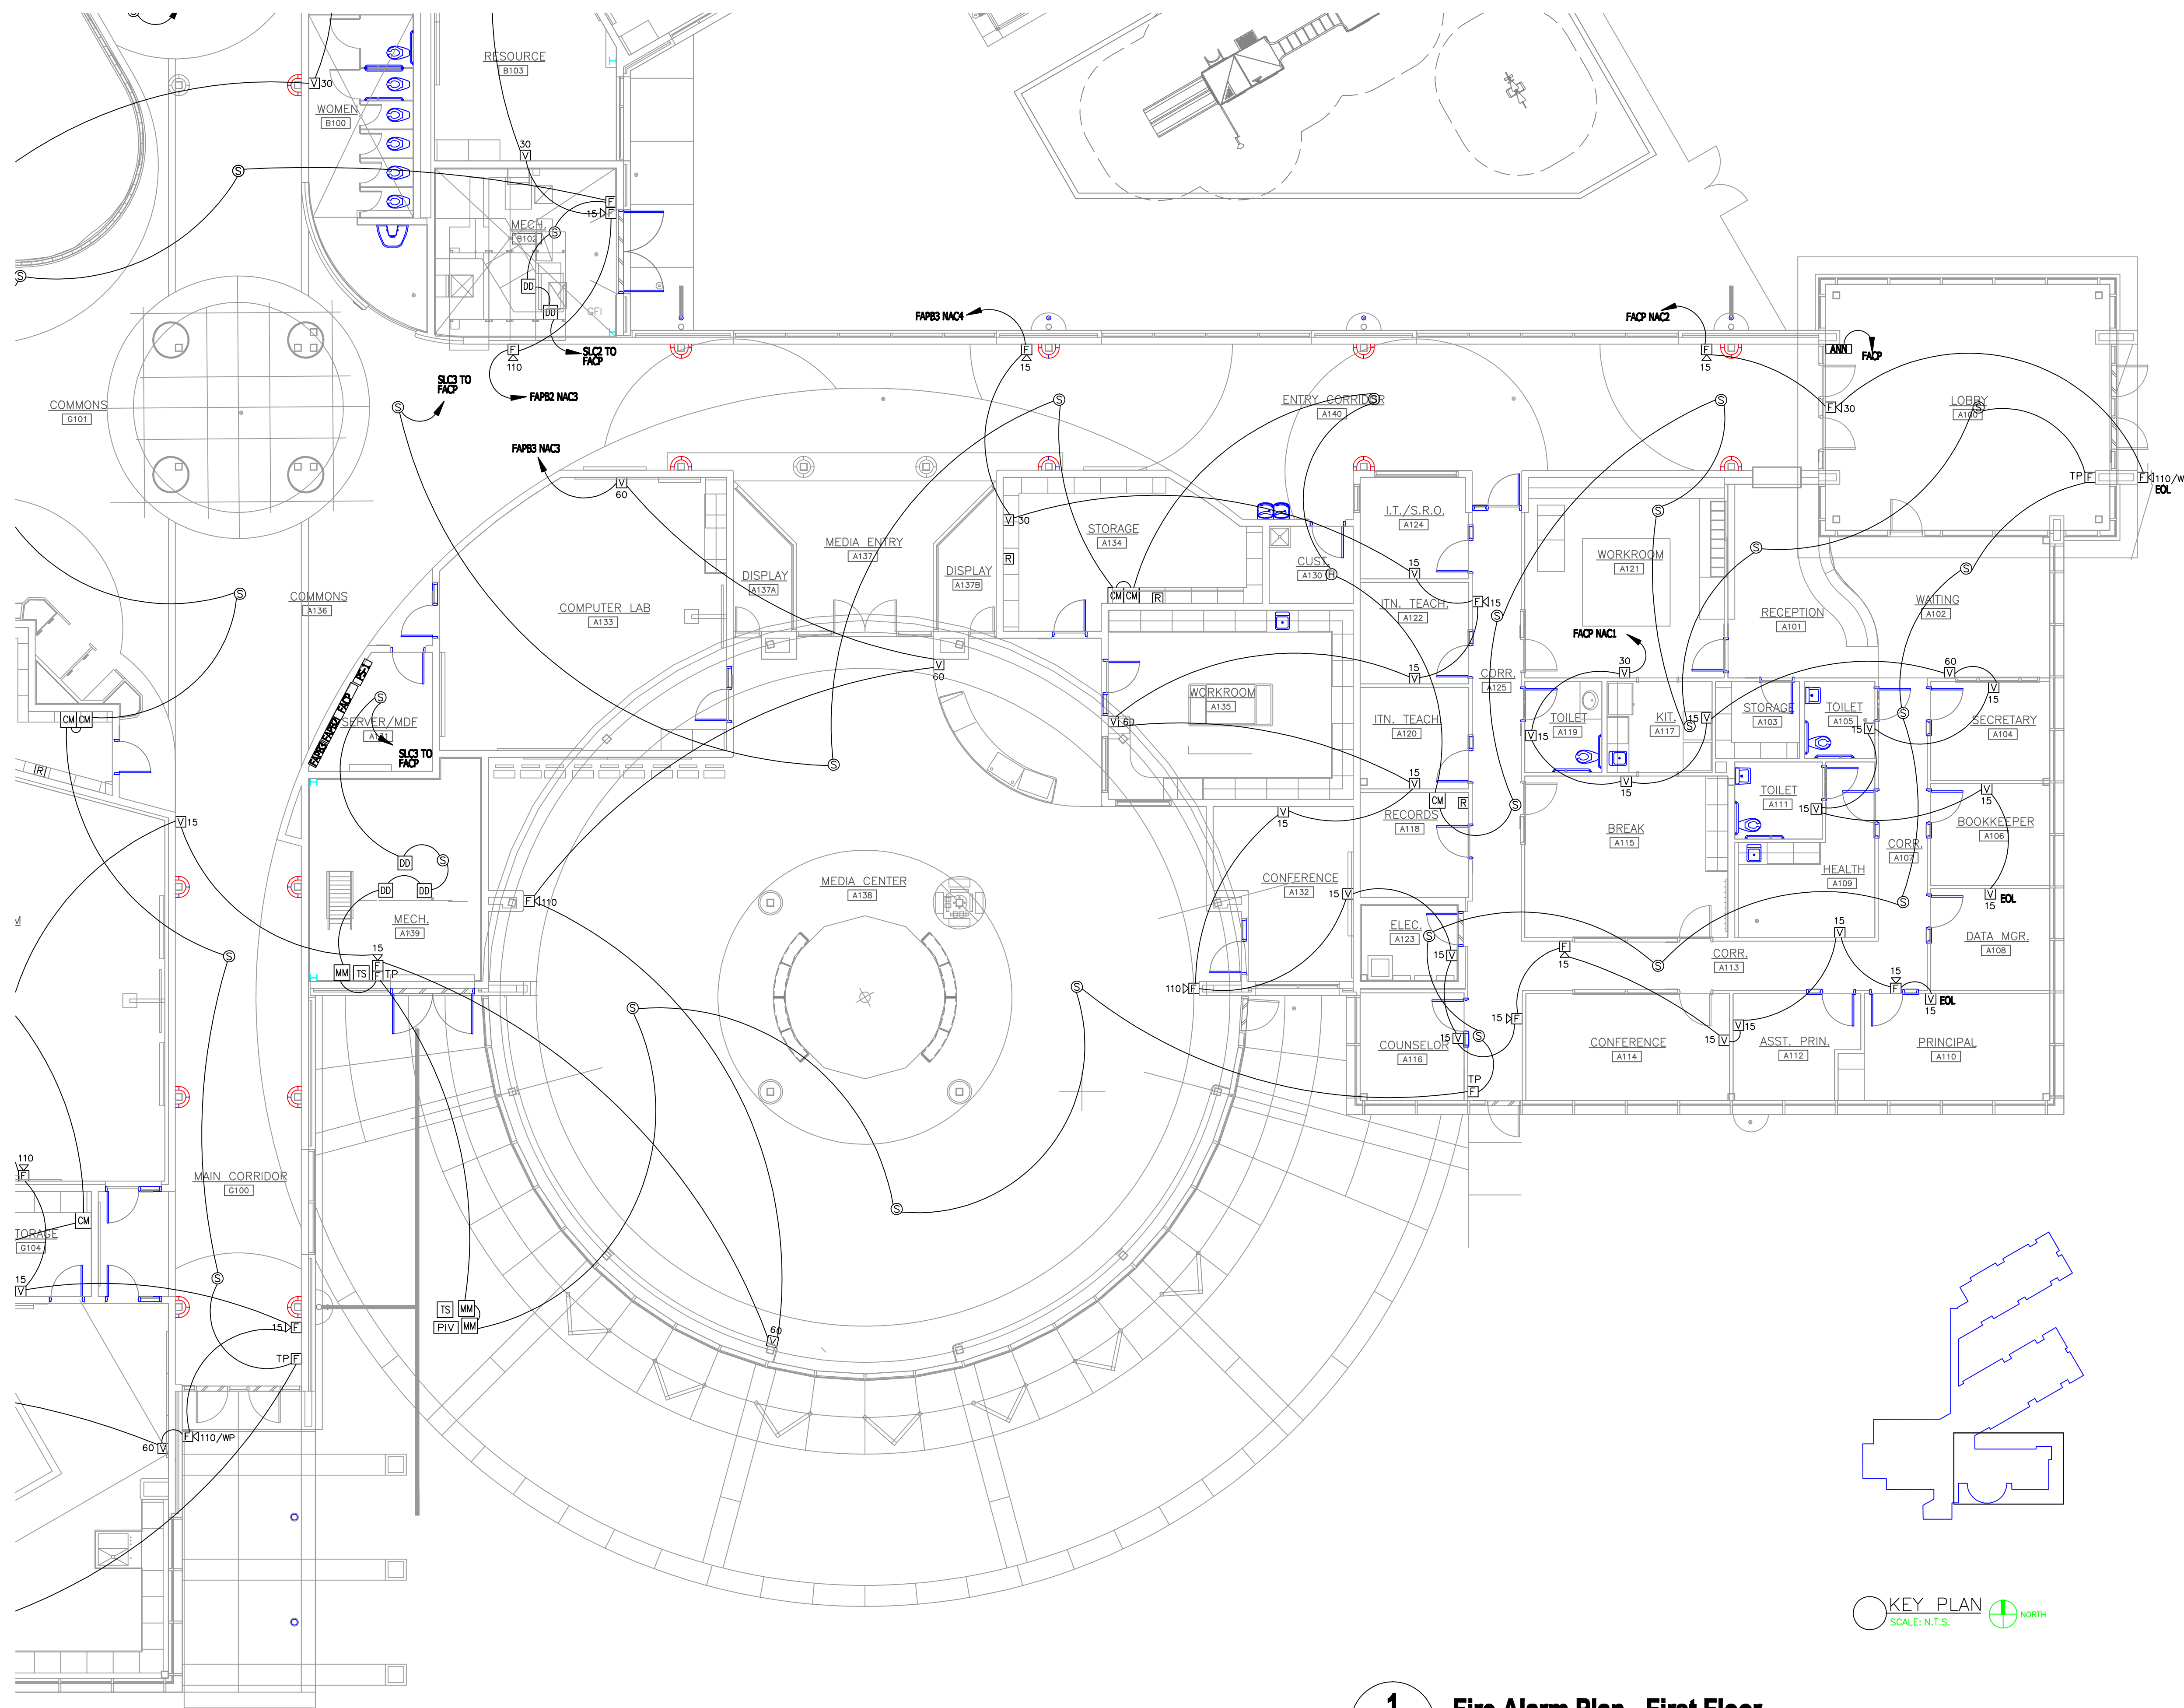

**1**  
**FA3** Fire Alarm Plan - First Floor  
 SCALE: 1/8"=1'-0" ADMINISTRATION & MEDIA

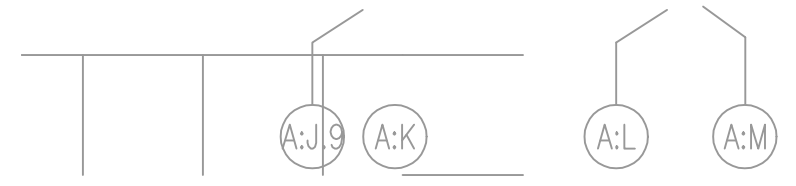

Drawing Title	FLOOR PLAN			
	Project No.	10-102-31	Drawn By	DWR
Revision	Date	Scale	N/A	Date
				5-12-10
Job:	Durham Elem. School - E 1470 Old Oxford Rd DURHAM, NC			
Contractor:				
SHEET 3 OF 9				