


THE PYROCADD COMPANY, LLC
 A FIRE SYSTEM DESIGN FIRM
 P.O. Box 51357
 Myrtle Beach, SC 29579
 www.pyrocadd.com

PHONE: Myrtle Beach 843-743-4888
 Raleigh, NC 919-212-2765
 Tel. Fax: 919-212-2356
 EMAIL: PYROCADD@GMAIL.COM



3609 Boston Lane
 Raleigh, NC 27604
 Tel: 919.212.2356
 Fax: 919.212.2357

www.piedmontfire.com

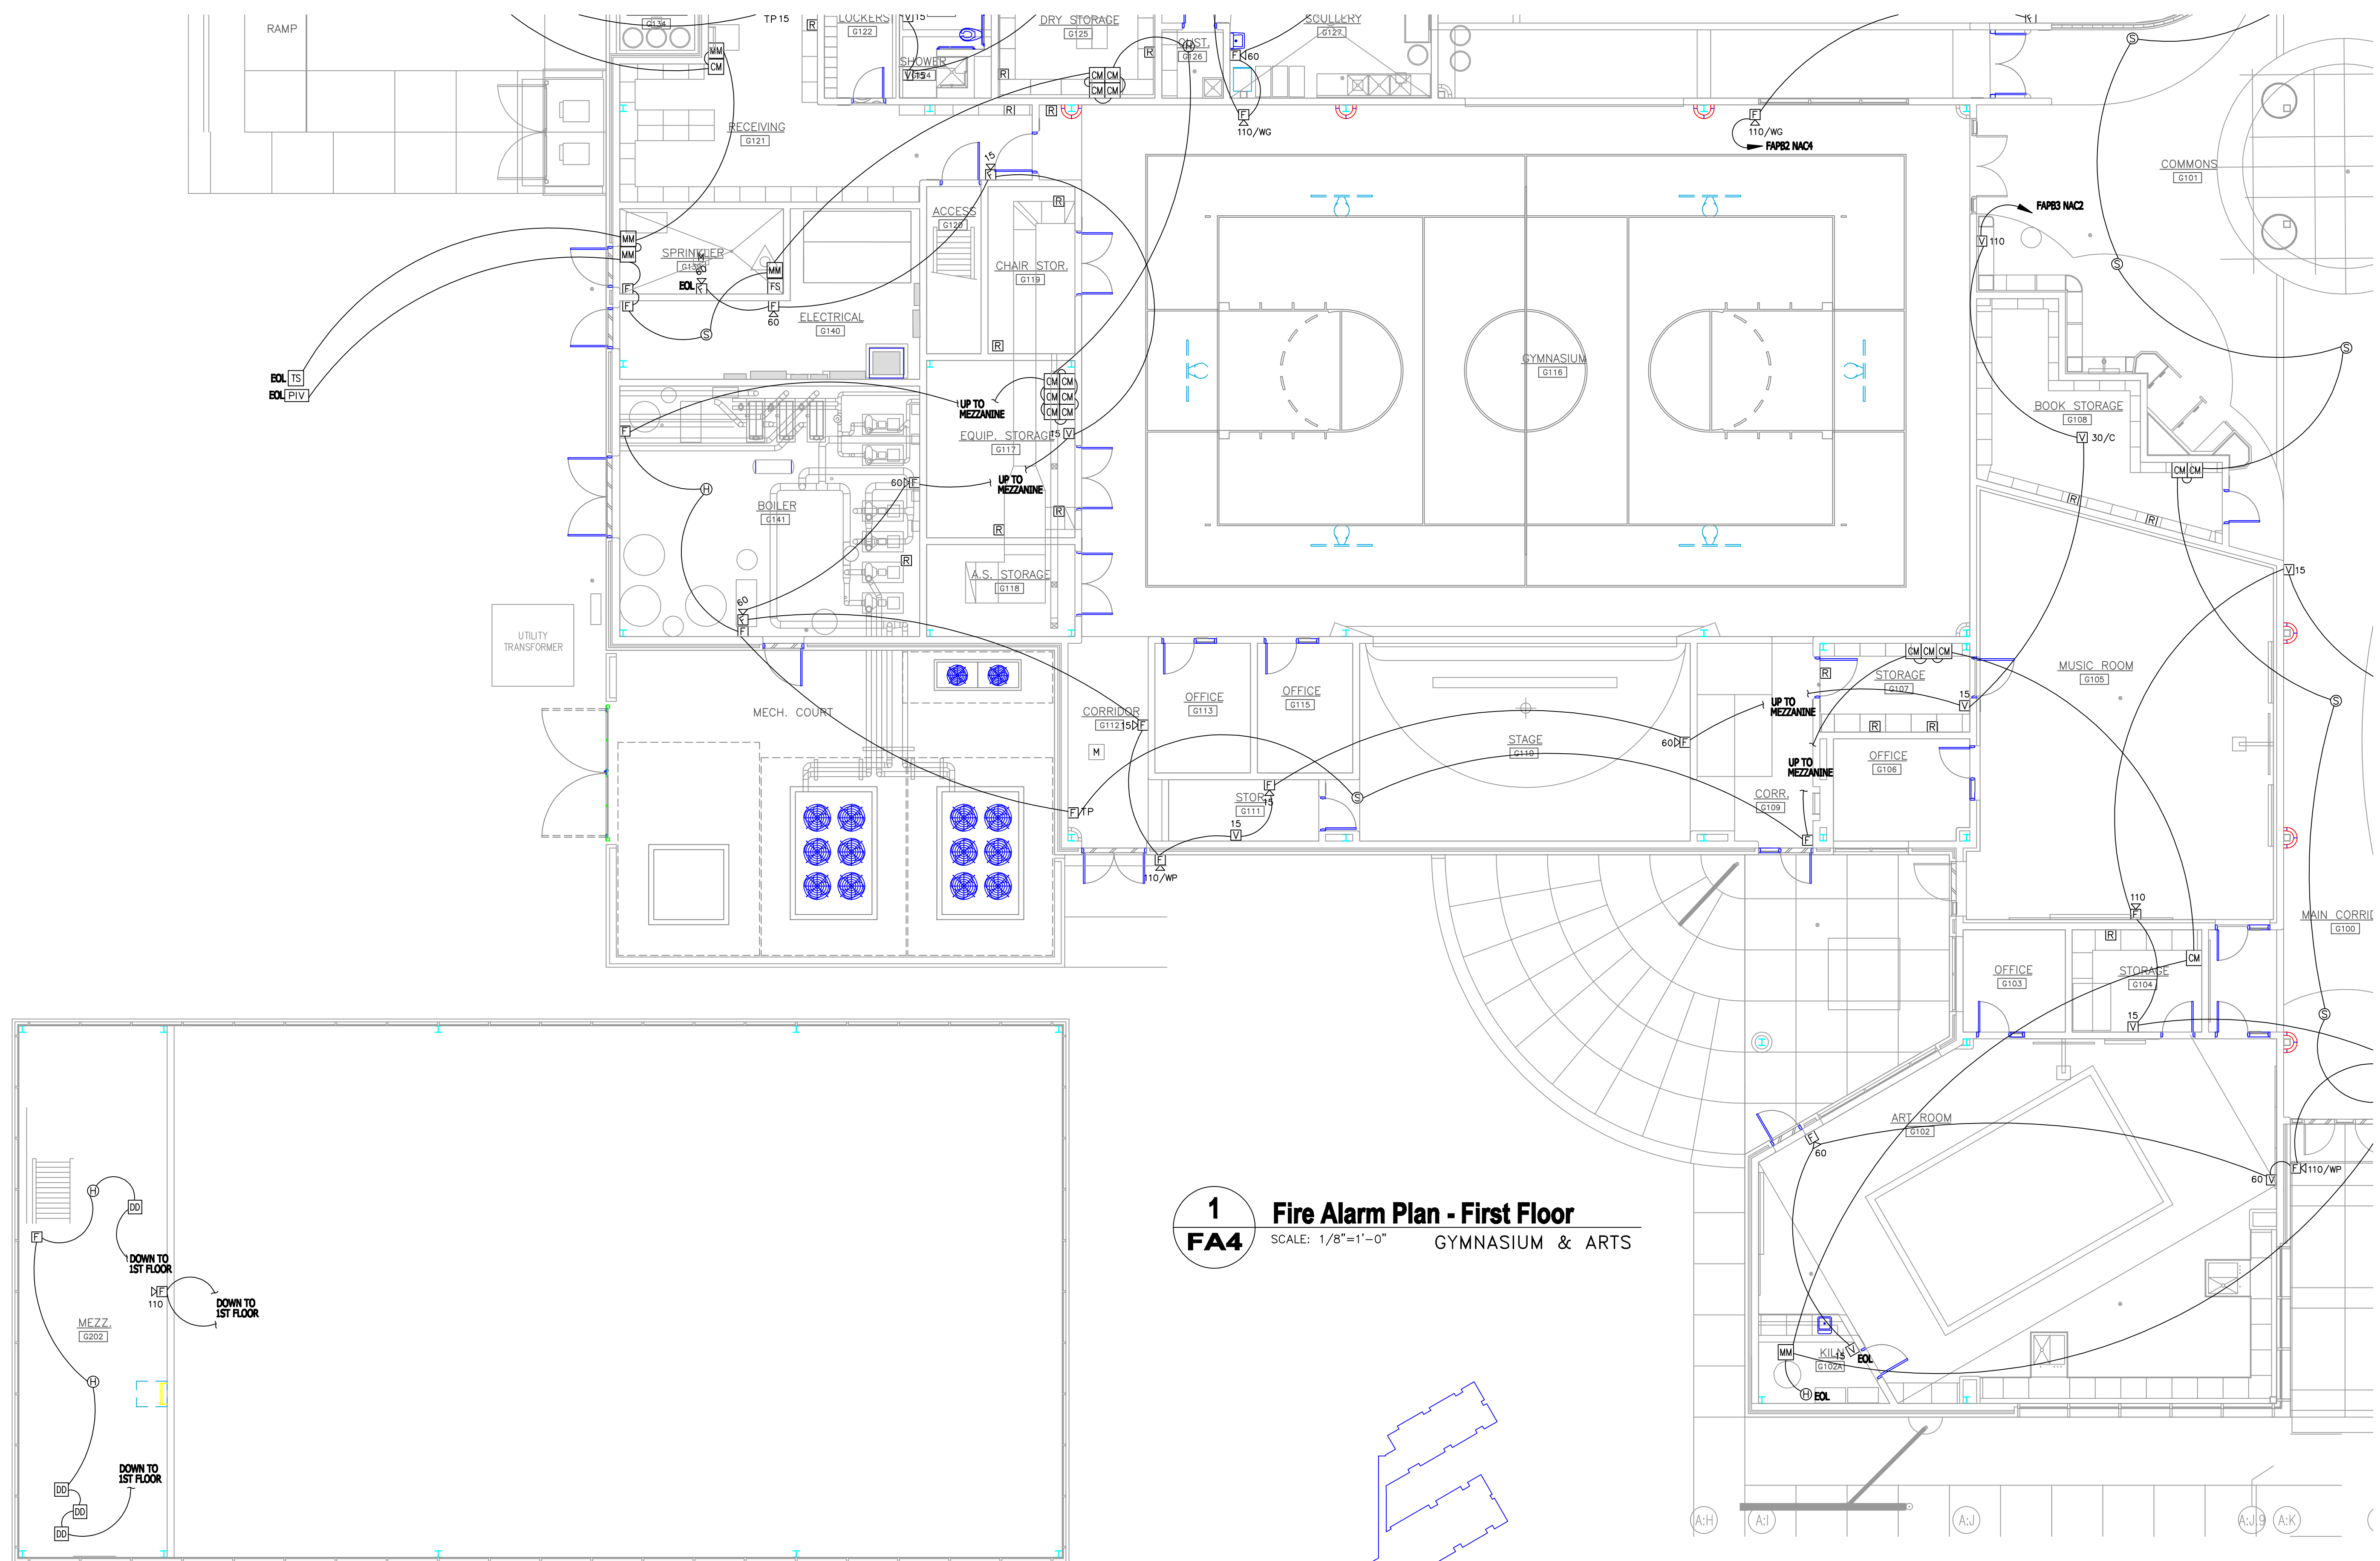

1
FA4 Fire Alarm Plan - First Floor
 SCALE: 1/8"=1'-0" GYMNASIUM & ARTS



2
FA4 Fire Alarm Plan - Mezzanine
 SCALE: 1/8"=1'-0"



| | | | |
|---------------|----------------------------------|-----------|---------|
| Drawing Title | FLOOR PLAN | | |
| | Project No. | 10-102-31 | Date |
| Drawn By | DWR | Scale | N/A |
| Contractor | | Date | 5-12-10 |
| Job: | Durham Elem. School—E | | |
| | 1470 Old Oxford Rd DURHAM, NC | | |
| SHEET | 4 OF 9 | | |