


KEY PLAN
 SCALE: N.T.S. NORTH

1 Fire Alarm Plan - First Floor
FA5 SCALE: 1/8"=1'-0" CAFETERIA & COMMONS

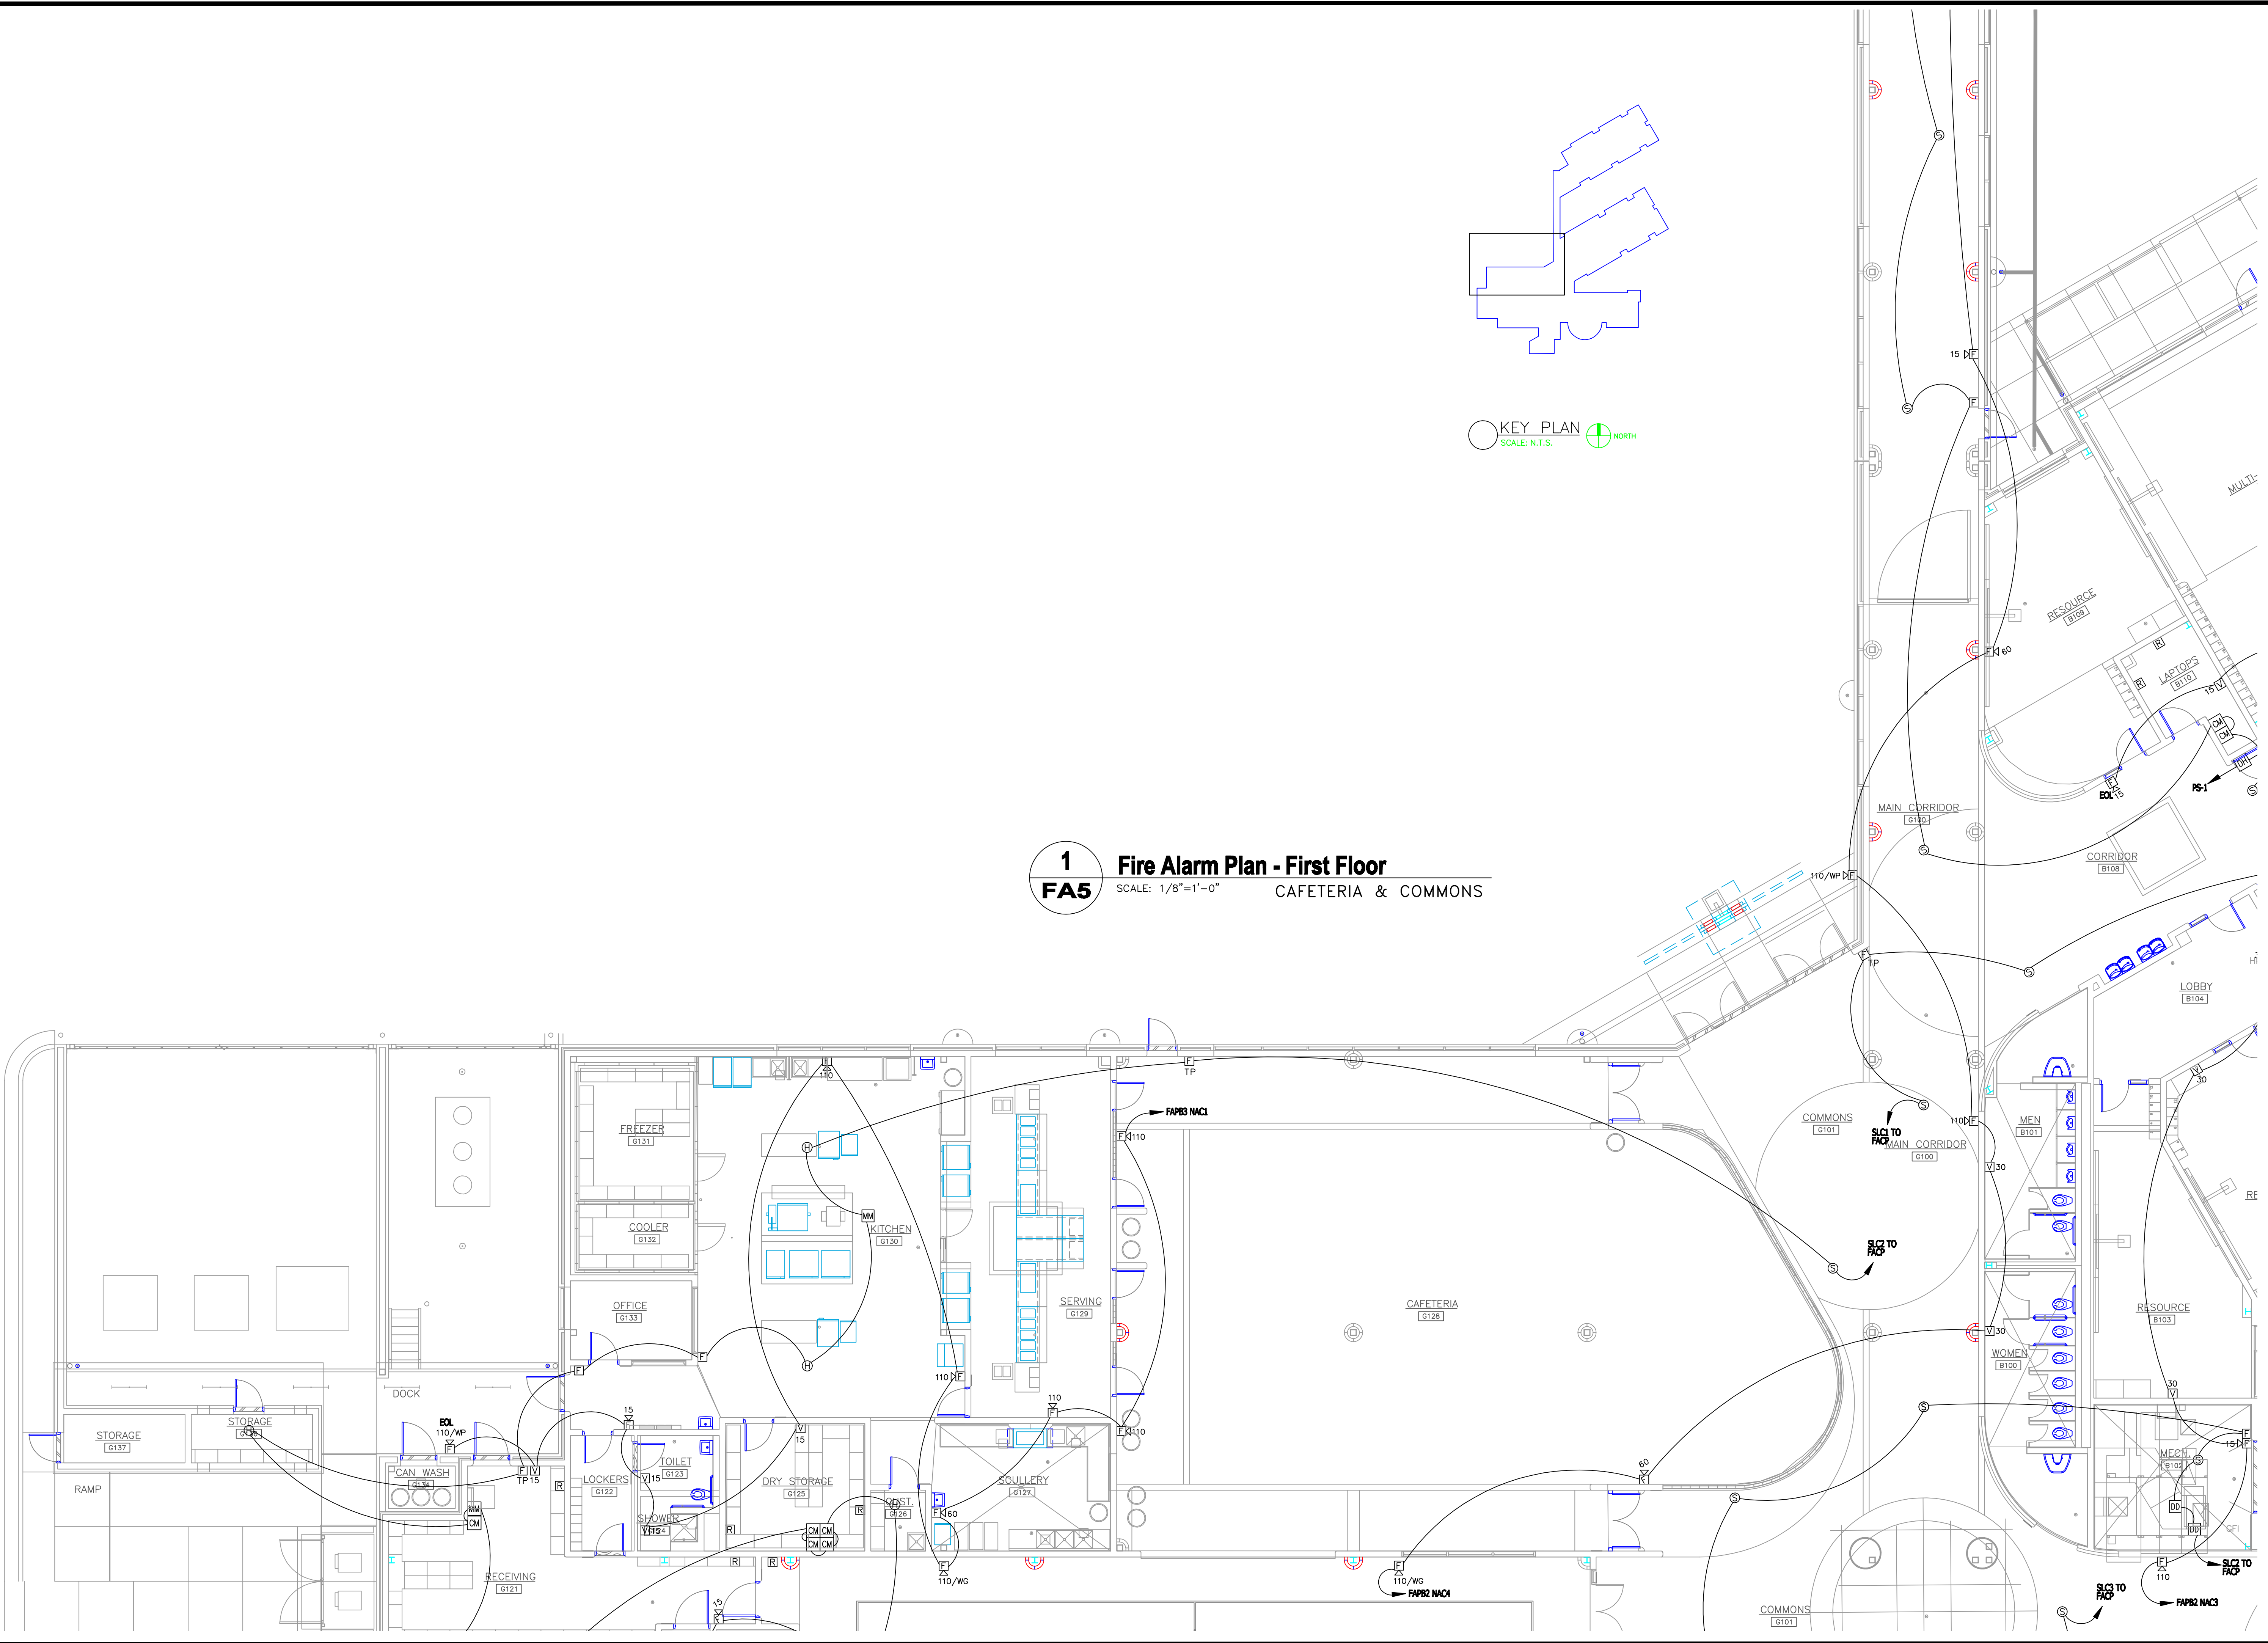

Drawing Title	FLOOR PLAN	Proj. No.	10-102-31	Drawn By	DWR	Scale	N/A	Date	5-12-10
Job	Durham Elem. School - E								
Address	1470 Old Oxford Rd DURHAM, NC								
Contractor									
SHEET 5 OF 9									